

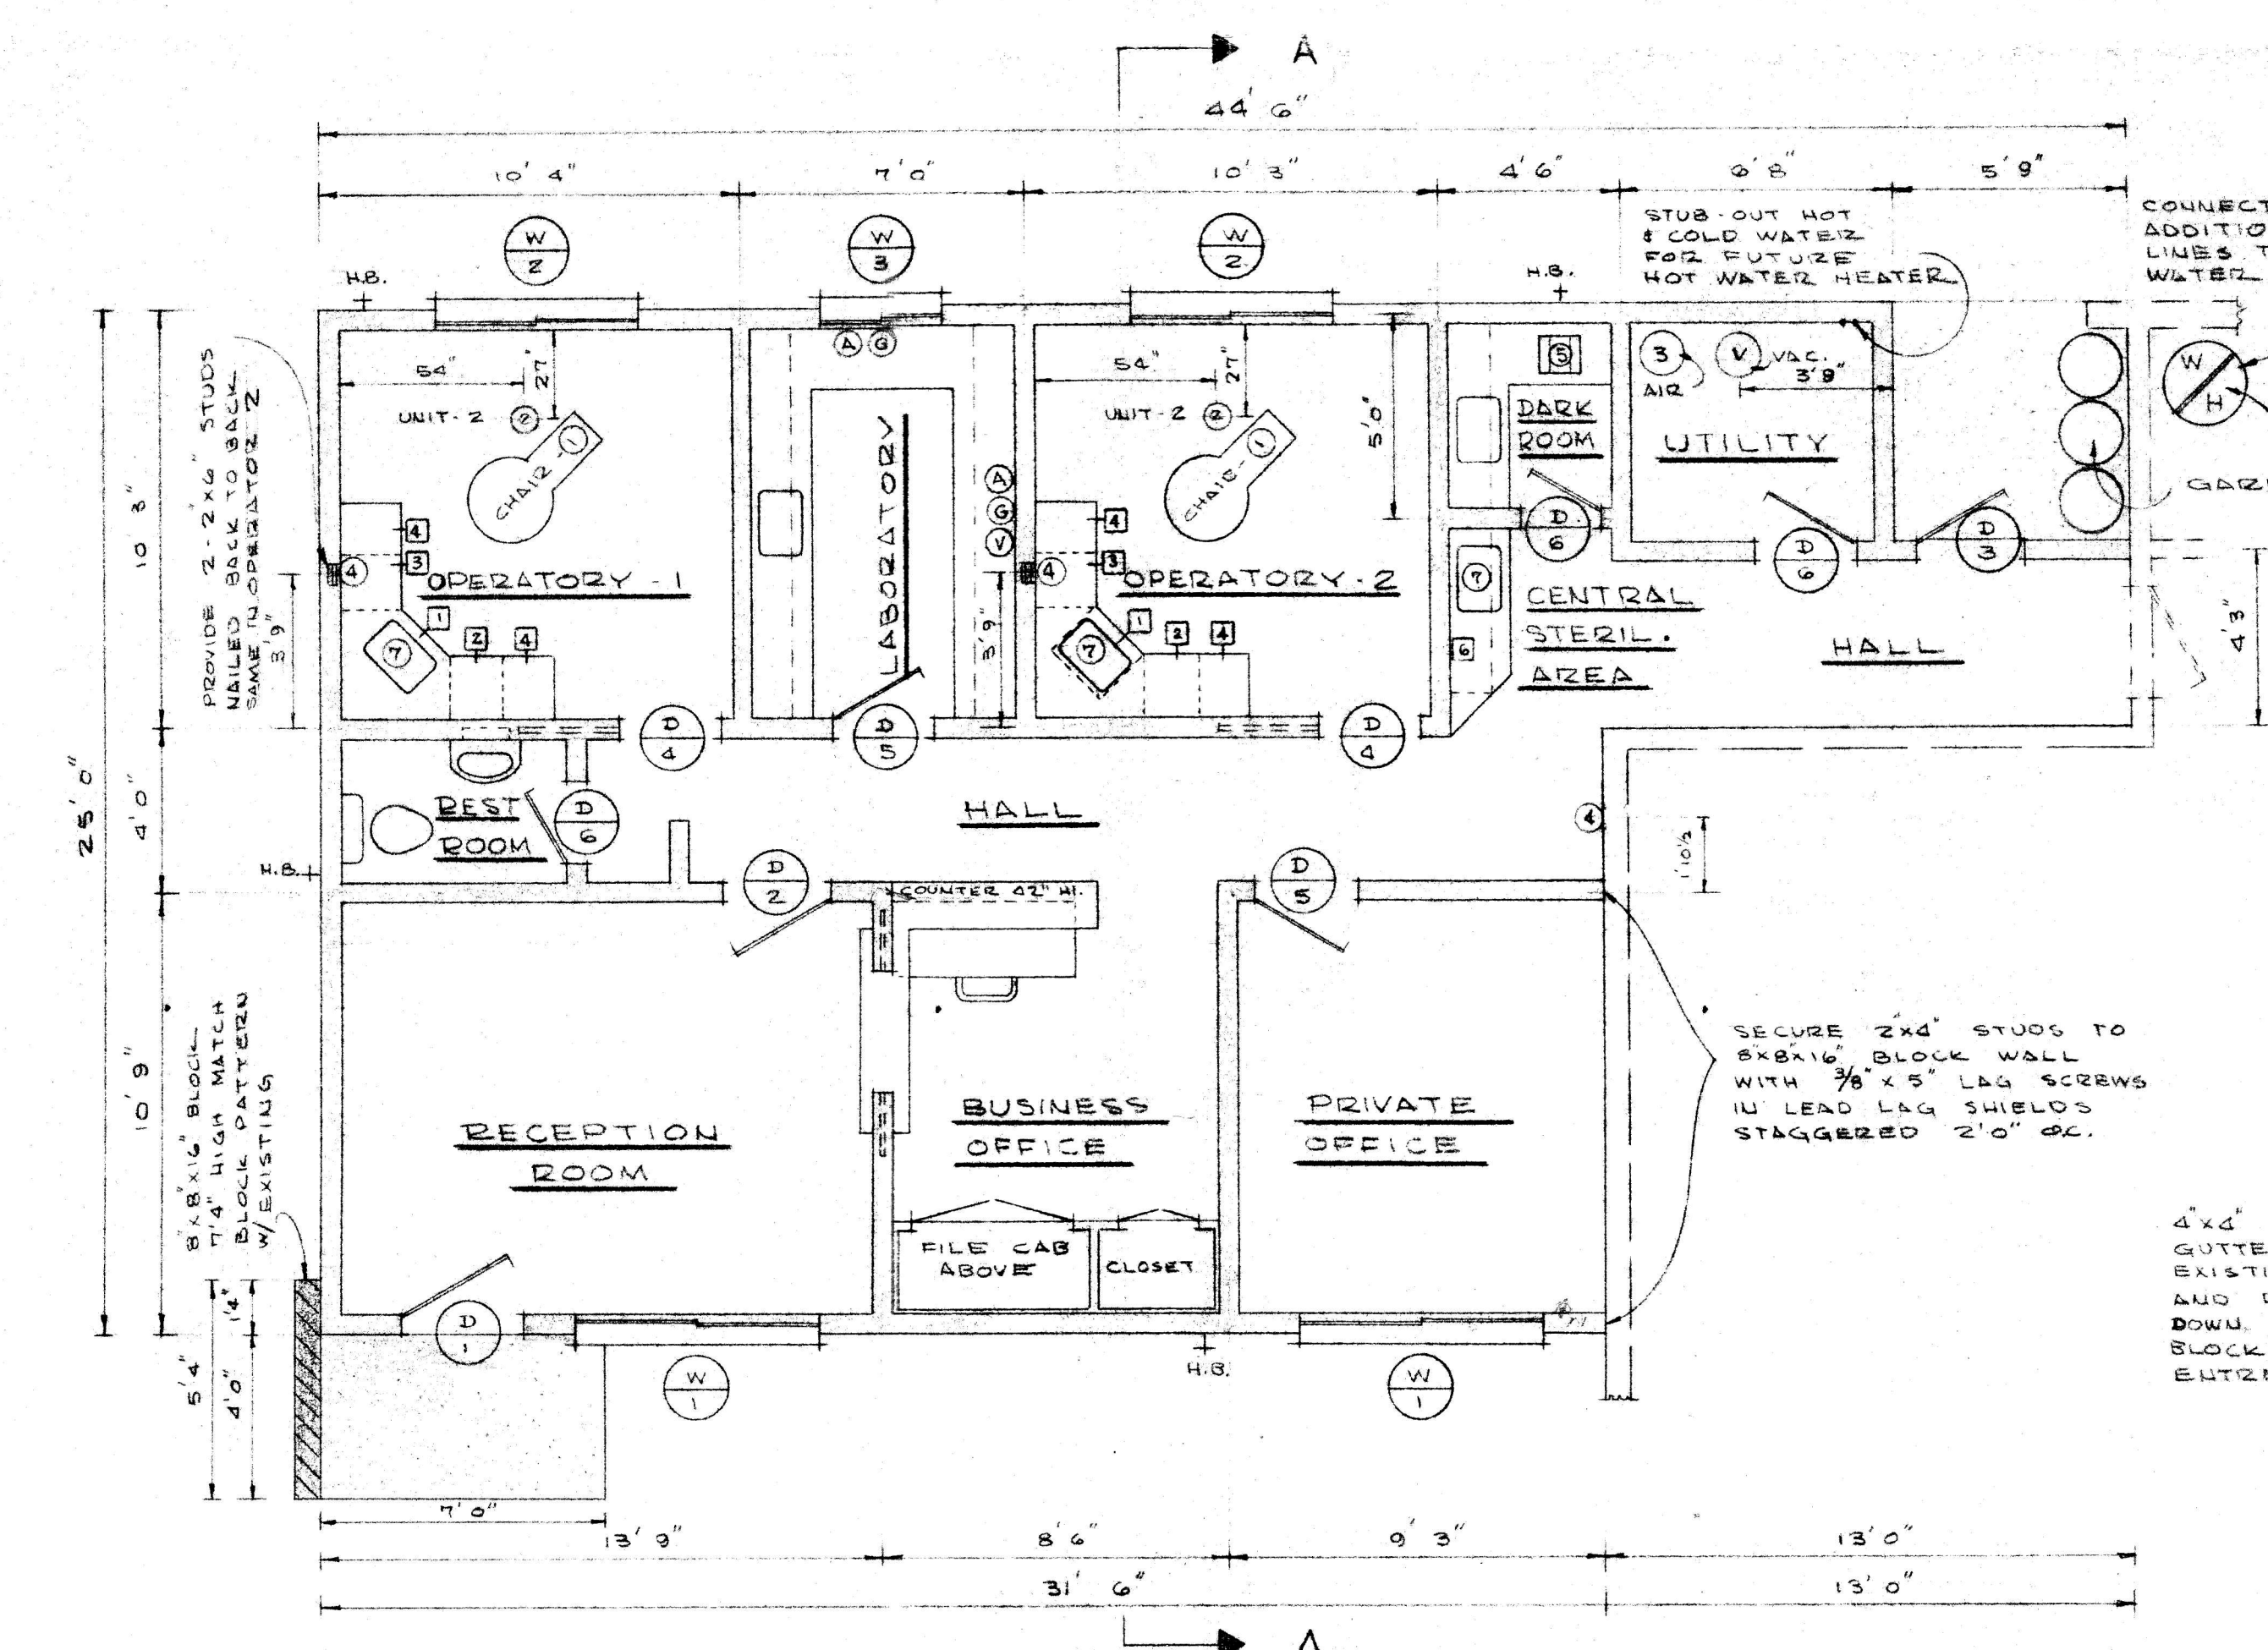


ROOF FRAMING PLAN

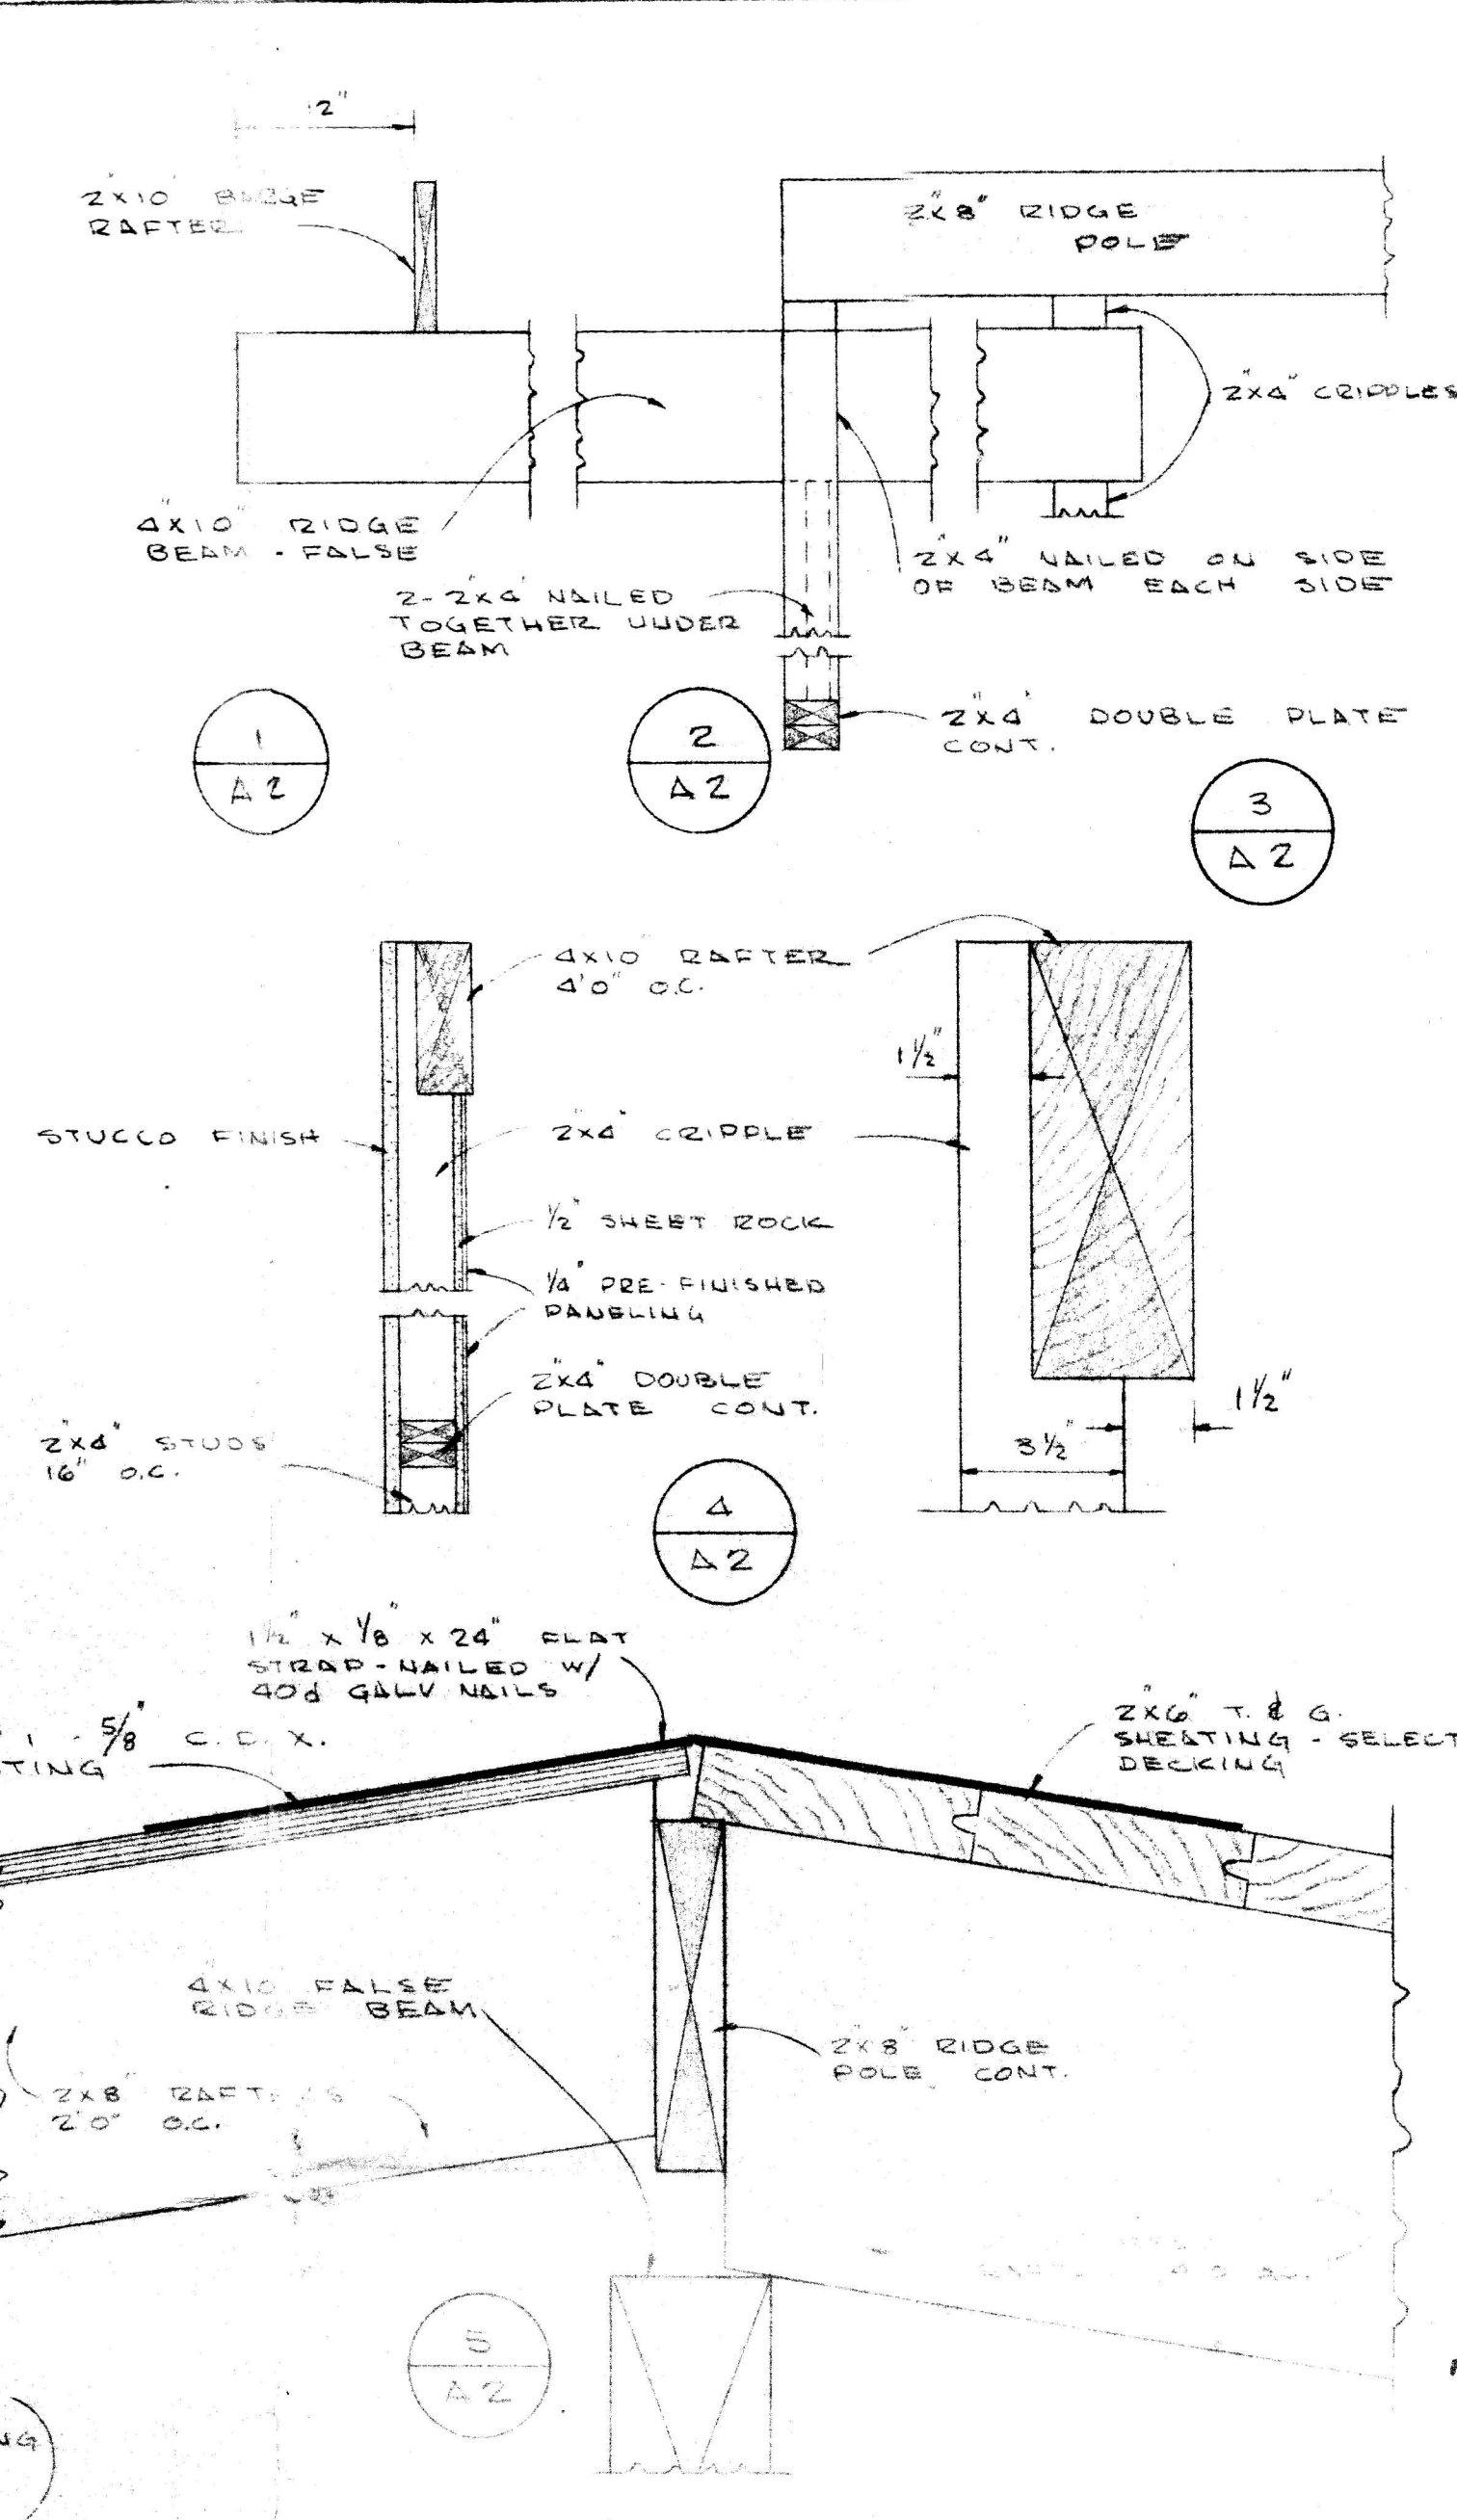

FLOOR PLAN

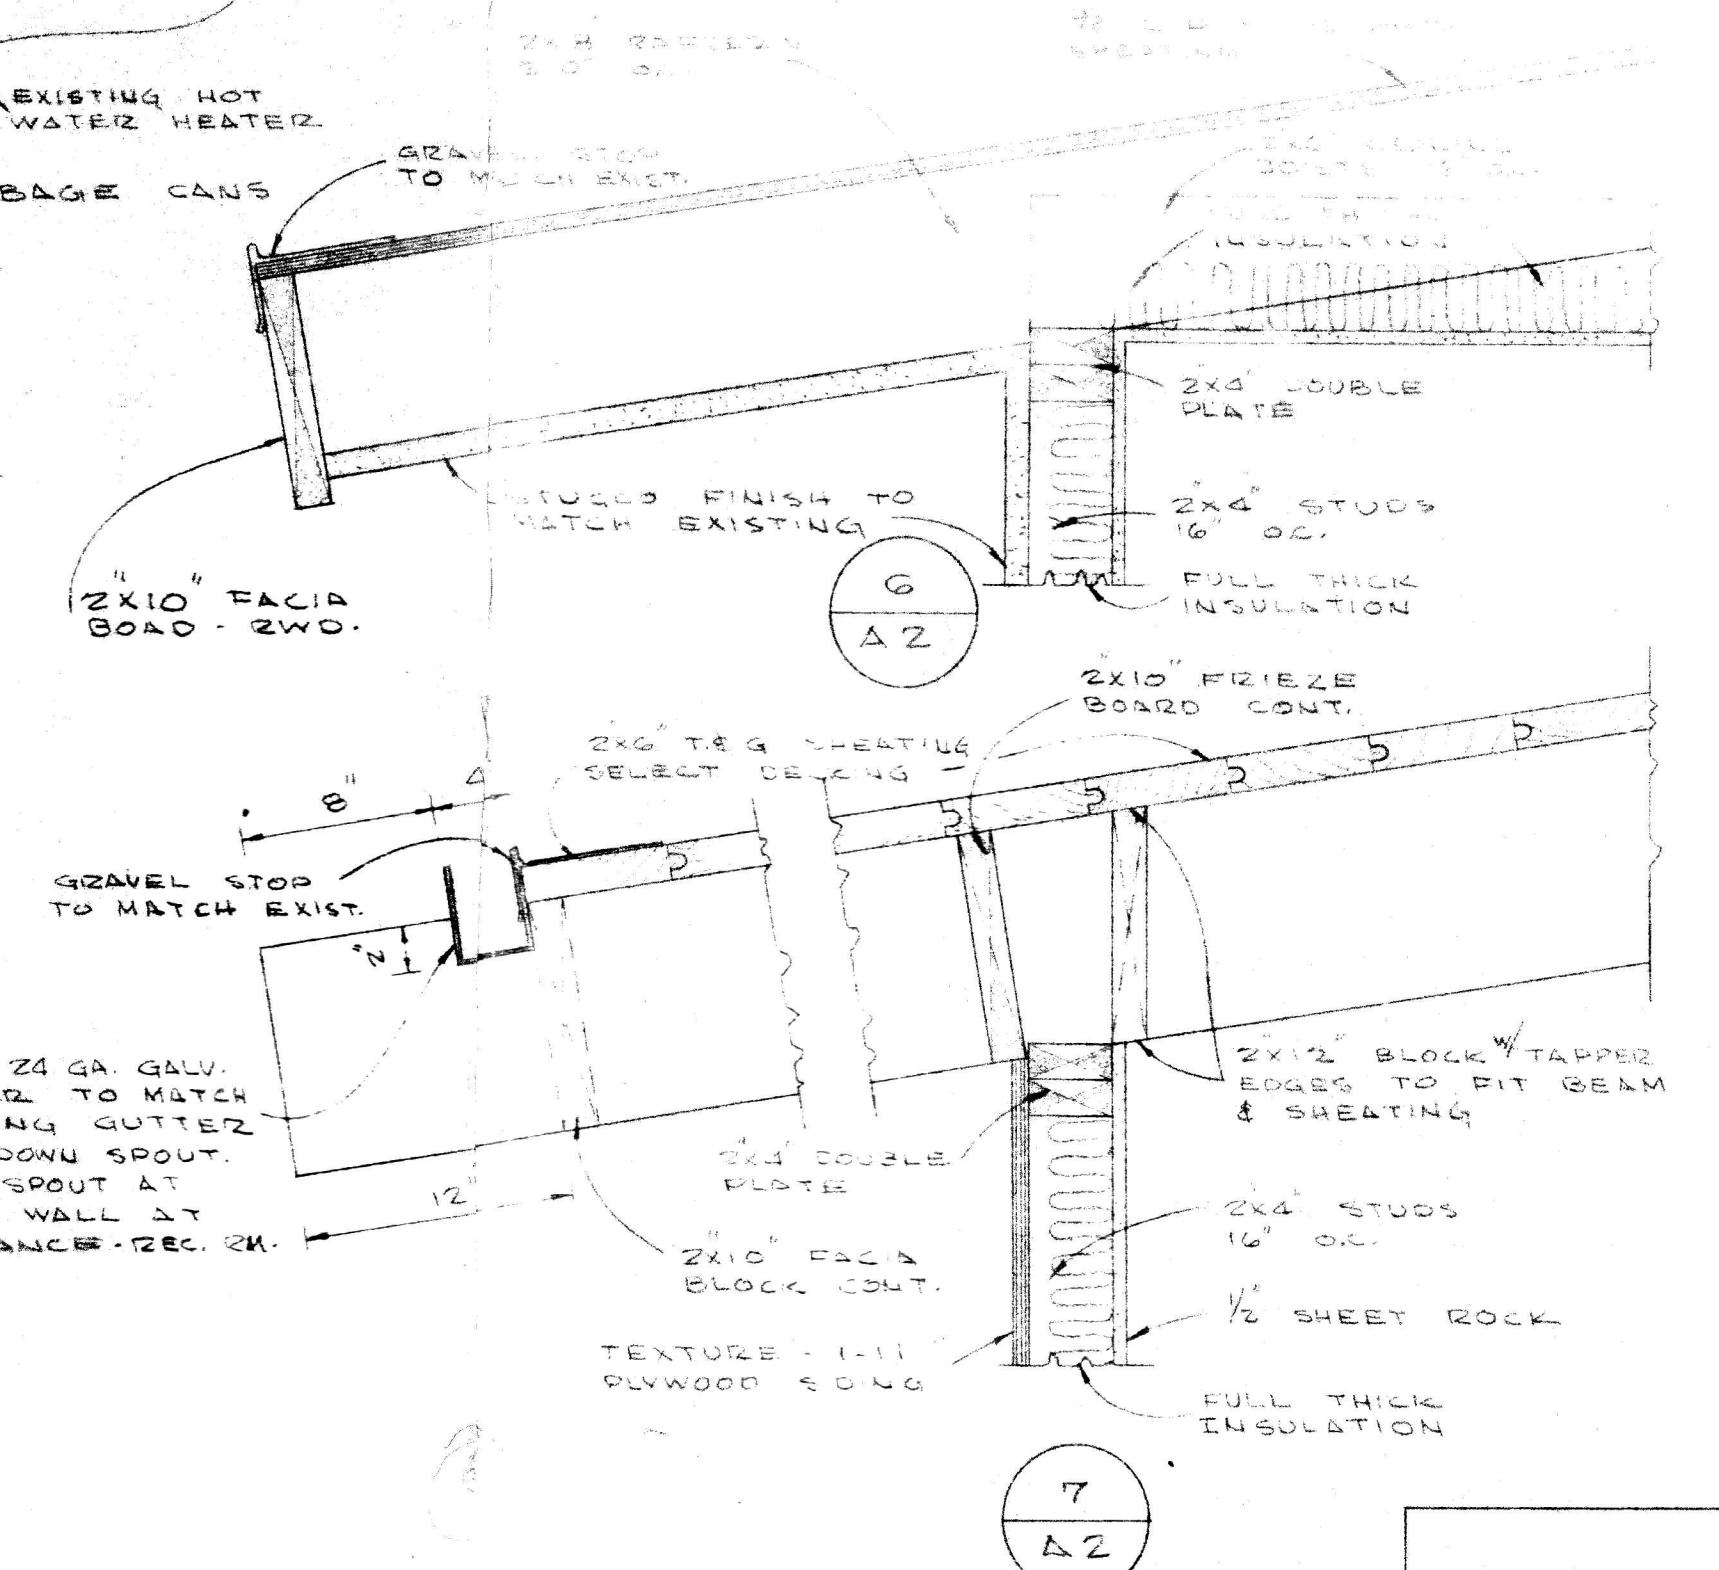

ZOOM LOCATION	FLOOR	WALLS	Ceilings	FLOOR	REMARKS
RECEPTION ROOM	OZITE CARPET	1/2 SHEET ROCK #DZE. FIN. PAU	2x4 STUDS 16" O.C.	2x4 STUDS 16" O.C.	REMOVE EXISTING WALL TO MATCH NEW WALL TO MATCH EXISTING WALLS W/ FULL THICK INSULATION
BUSINESS OFFICE	"	"	"	"	REMOVE EXISTING WALL TO MATCH NEW WALL TO MATCH EXISTING WALLS W/ FULL THICK INSULATION
PRIVATE OFFICE	"	"	"	"	REMOVE EXISTING WALL TO MATCH NEW WALL TO MATCH EXISTING WALLS W/ FULL THICK INSULATION
OPERATORY 1	"	"	"	"	REMOVE EXISTING WALL TO MATCH NEW WALL TO MATCH EXISTING WALLS W/ FULL THICK INSULATION
OPERATORY 2	"	"	"	"	REMOVE EXISTING WALL TO MATCH NEW WALL TO MATCH EXISTING WALLS W/ FULL THICK INSULATION
LABORATORY	VINYL ASP. TILE	"	"	"	REMOVE EXISTING WALL TO MATCH NEW WALL TO MATCH EXISTING WALLS W/ FULL THICK INSULATION
CENT. STERIL. AREA	OZITE CARPET	"	"	"	REMOVE EXISTING WALL TO MATCH NEW WALL TO MATCH EXISTING WALLS W/ FULL THICK INSULATION
DARK ROOM	VINYL ASP. TILE	"	"	"	REMOVE EXISTING WALL TO MATCH NEW WALL TO MATCH EXISTING WALLS W/ FULL THICK INSULATION
UTILITY ROOM	VINYL ASP. TILE	"	"	"	REMOVE EXISTING WALL TO MATCH NEW WALL TO MATCH EXISTING WALLS W/ FULL THICK INSULATION
HALL	OZITE CARPET	"	"	"	REMOVE EXISTING WALL TO MATCH NEW WALL TO MATCH EXISTING WALLS W/ FULL THICK INSULATION
REST ROOM	VINYL ASP. TILE	"	"	"	REMOVE EXISTING WALL TO MATCH NEW WALL TO MATCH EXISTING WALLS W/ FULL THICK INSULATION


DOOR LOC.	SIZE	THICK	TYPE	REMARKS
D 1	32" x 62"	1 3/4"	FLUSH - SOLID	EXISTING
D 2	28" x 62"	1 3/8"	"	"
D 3	26" x 62"	1 3/4"	FLUSH - SOLID	"
D 4	24" x 62"	1 3/8"	"	"
D 5	26" x 62"	1 3/8"	FLUSH - HOLLOW	"
D 6	28" x 62"	1 3/8"	"	"
D 7				
D 8				
D 9				
D 10				

WINDOW LOC.	SIZE	THICK	TYPE	REMARKS
W 1	60" x 42"		APPLY FINISH	
W 2				
W 3				
W 4				


- EQUIPMENT
1. REMOVE EXISTING...
  2. REMOVE EXISTING WALL TO MATCH NEW WALL TO MATCH EXISTING WALLS W/ FULL THICK INSULATION
  3. REMOVE EXISTING WALL TO MATCH NEW WALL TO MATCH EXISTING WALLS W/ FULL THICK INSULATION
  4. REMOVE EXISTING WALL TO MATCH NEW WALL TO MATCH EXISTING WALLS W/ FULL THICK INSULATION
  5. REMOVE EXISTING WALL TO MATCH NEW WALL TO MATCH EXISTING WALLS W/ FULL THICK INSULATION
  6. REMOVE EXISTING WALL TO MATCH NEW WALL TO MATCH EXISTING WALLS W/ FULL THICK INSULATION
  7. REMOVE EXISTING WALL TO MATCH NEW WALL TO MATCH EXISTING WALLS W/ FULL THICK INSULATION
- NOTE: REMOVE EXISTING WALL TO MATCH NEW WALL TO MATCH EXISTING WALLS W/ FULL THICK INSULATION




CAMBRIA CLINIC ADDITION  
CAMBRIA HOSPITAL DISTRICT  
2220 SOUZA, A.I.B.D.  
388 - 3308  
CALIFORNIA

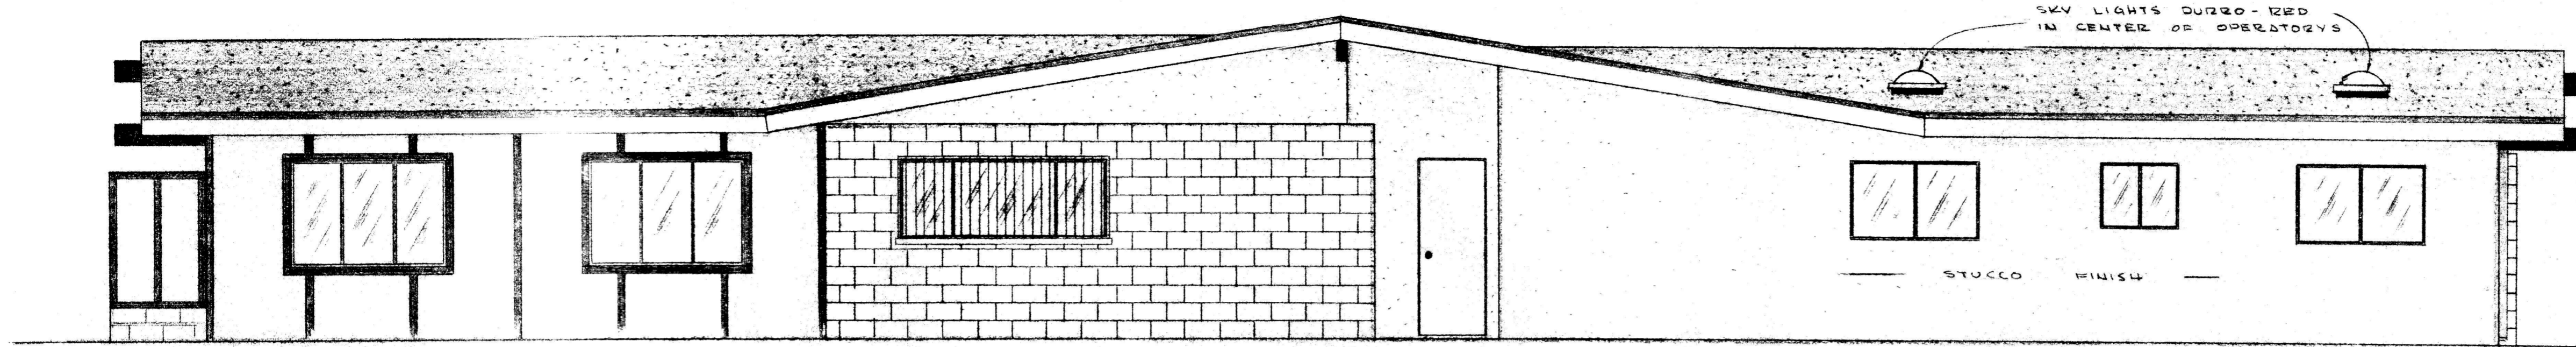

NORTH

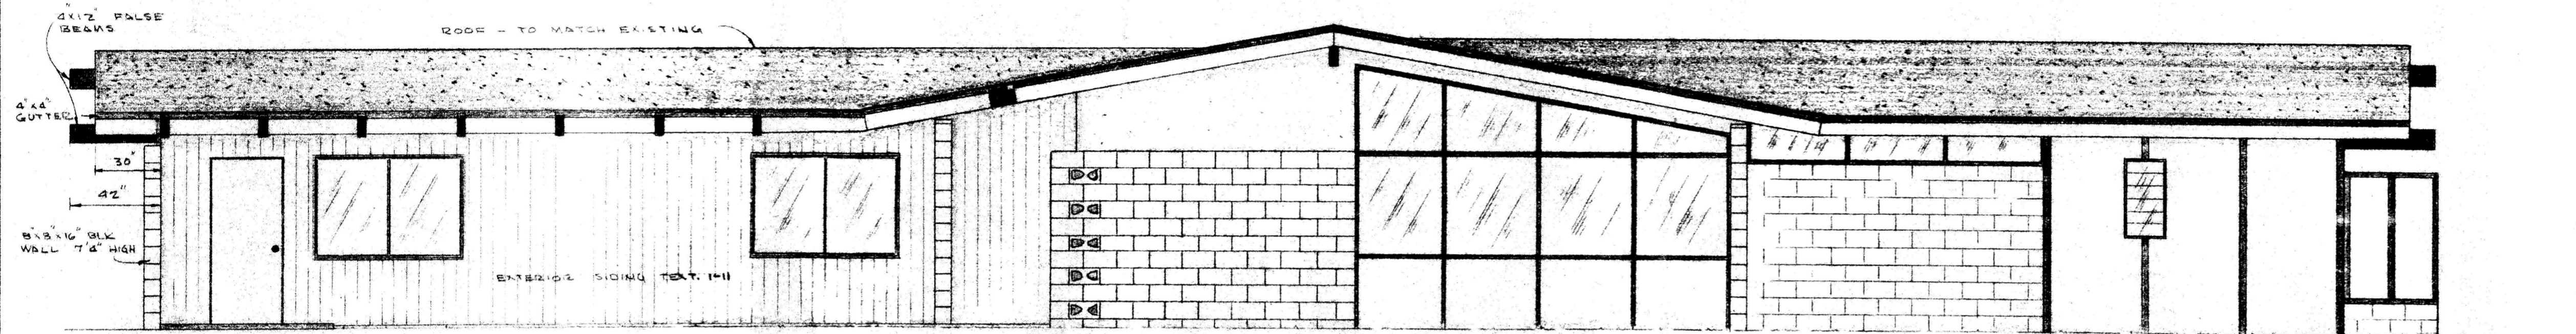


SOUTH

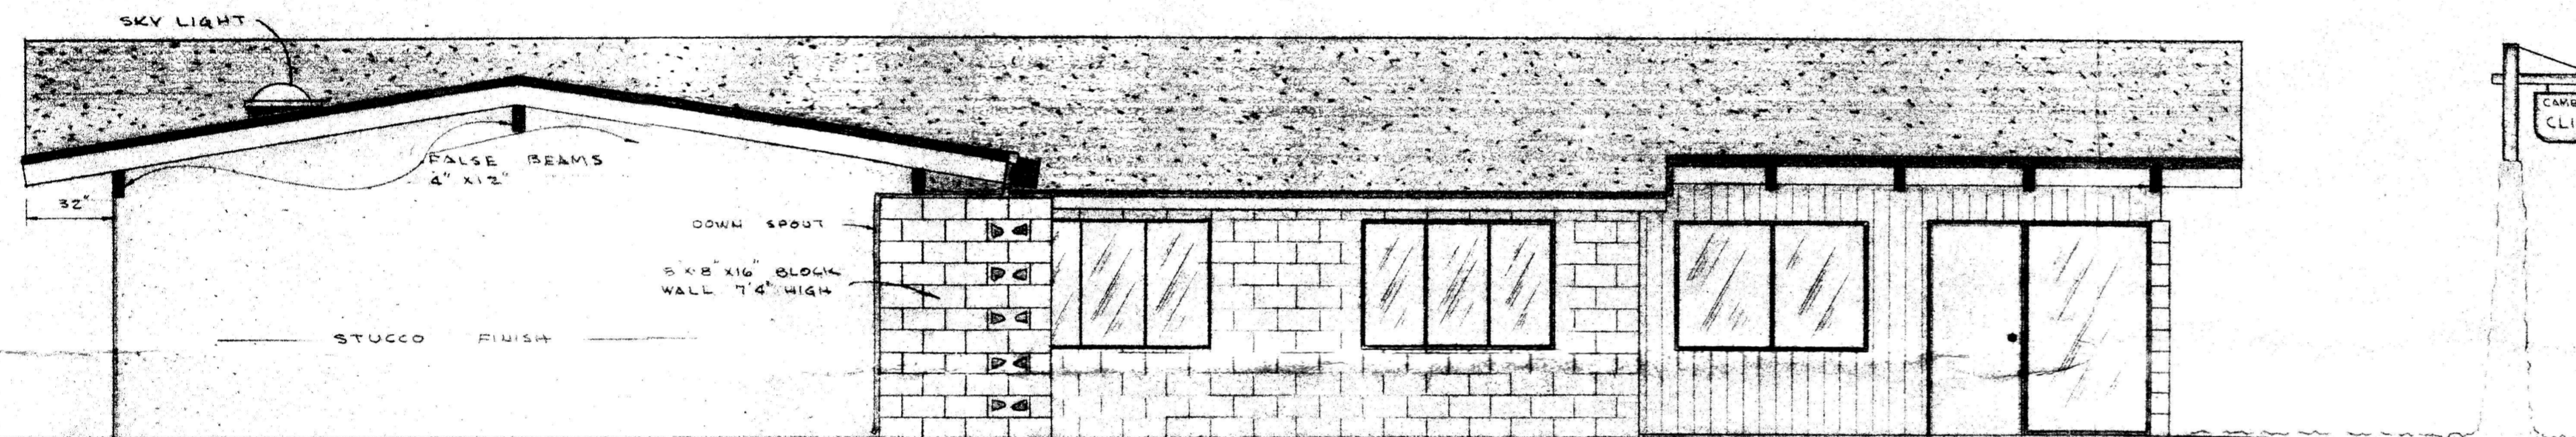

WEST


ELEVATIONS

SCALE: 1/4" = 1' 0"

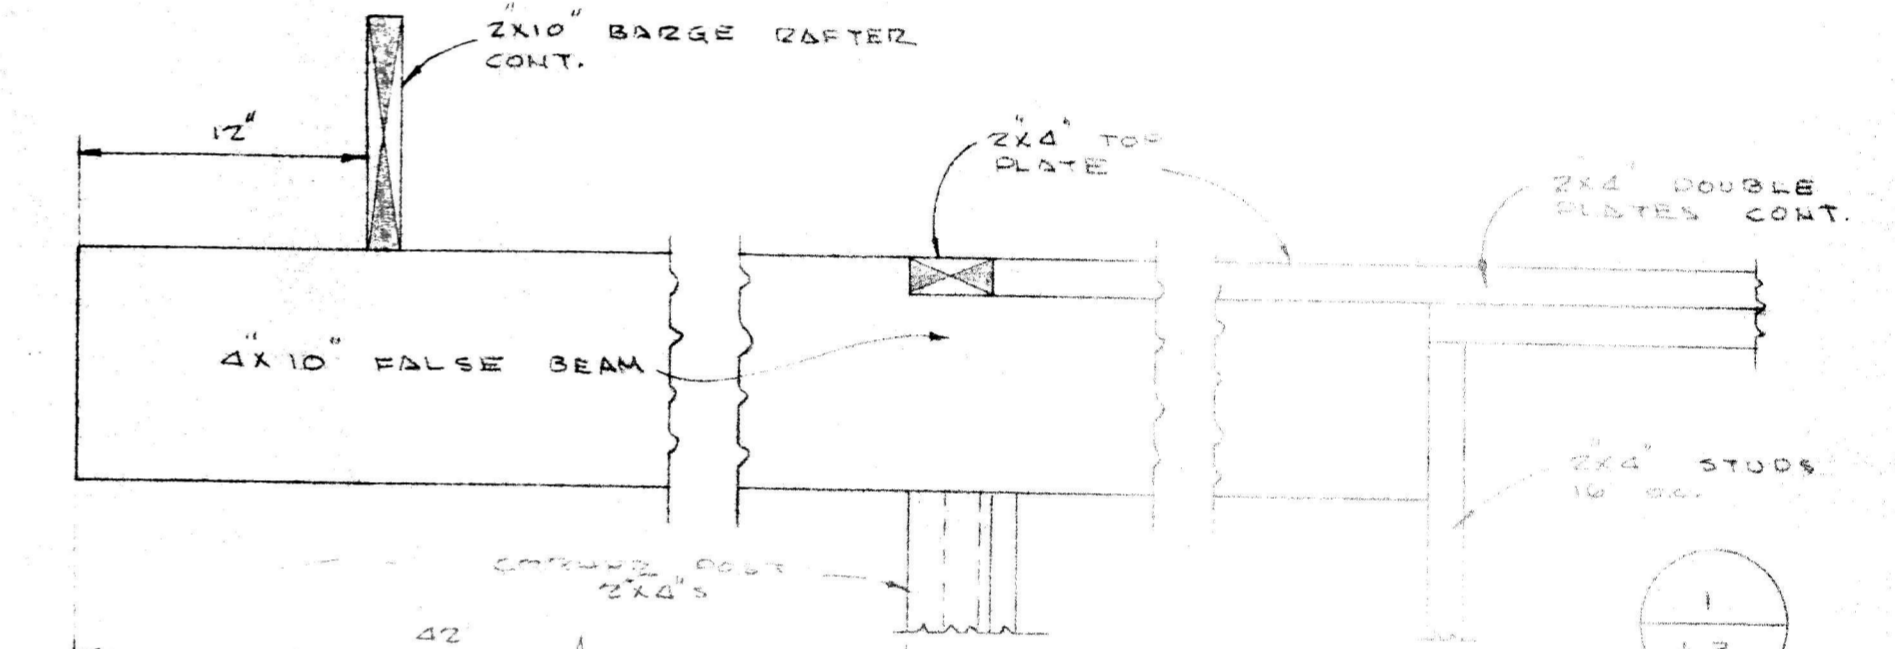


FALSE BEAM DETAIL

SCALE: 1/2" = 1' 0"

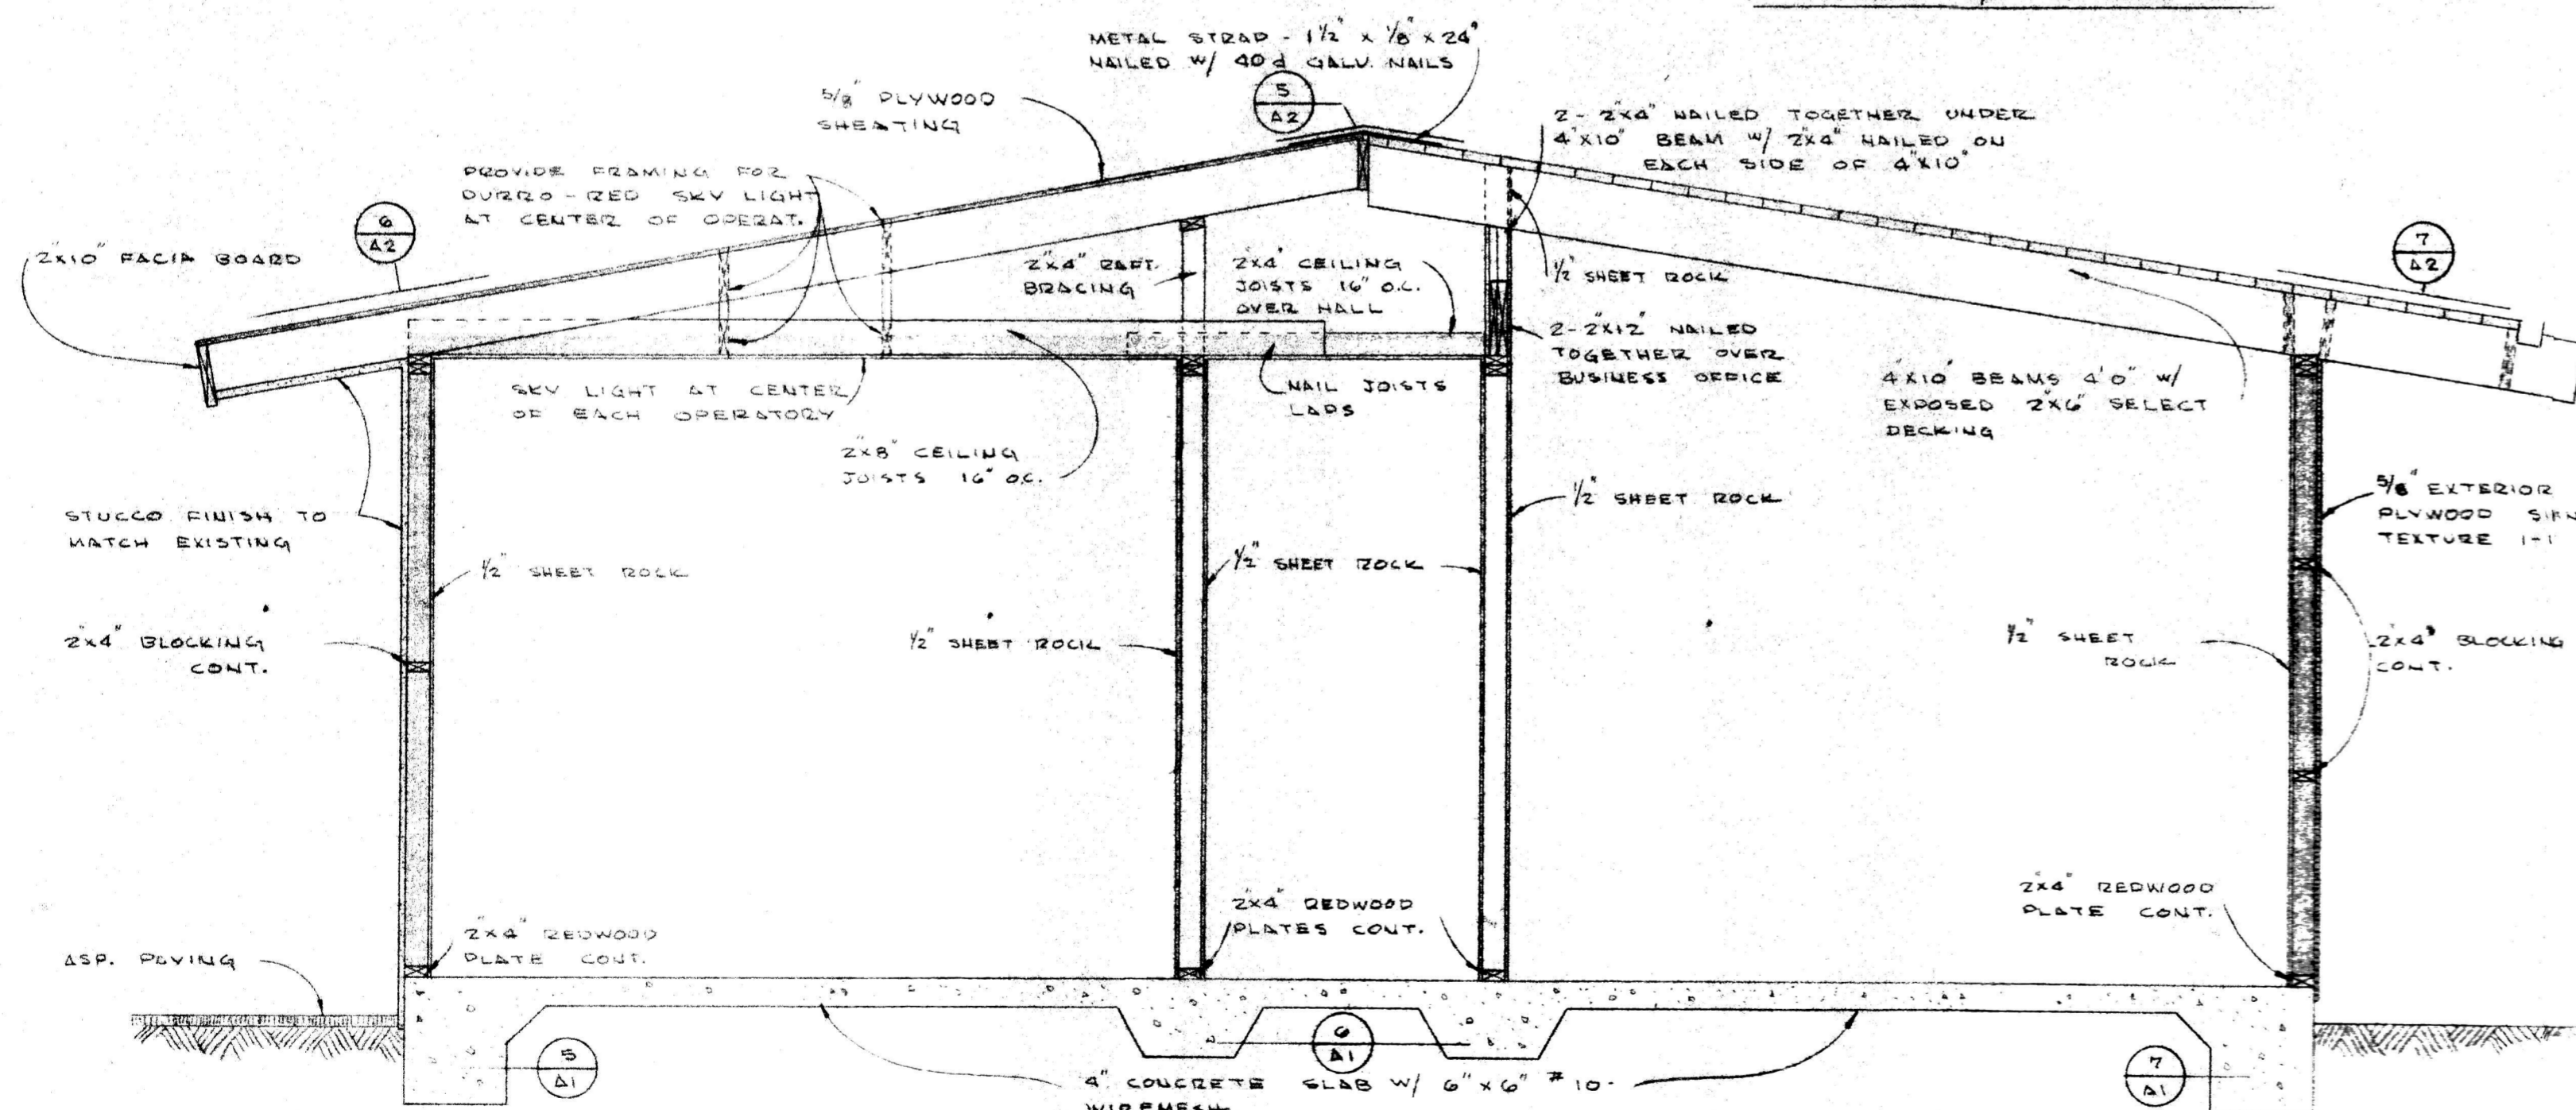


CROSS SECTION — AA

SCALE: 1/2" = 1' 0"

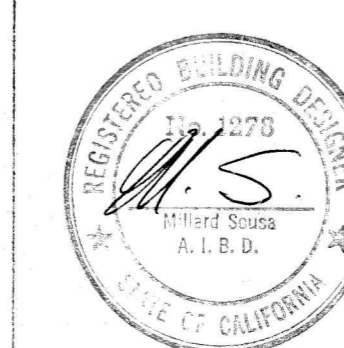


DATE  
3-24-57  
DRAWN BY  
M.S. 1278  
JOB NO.  
SHEET NO.  
A3  
OF 4

CAMBRIA CLINIC ADDITION  
CAMBRIA HOSPITAL DISTRICT  
MILLARD SOUZA, A.I.B.D.  
PHONE: 995-3308  
CAYUCOS, CALIFORNIA

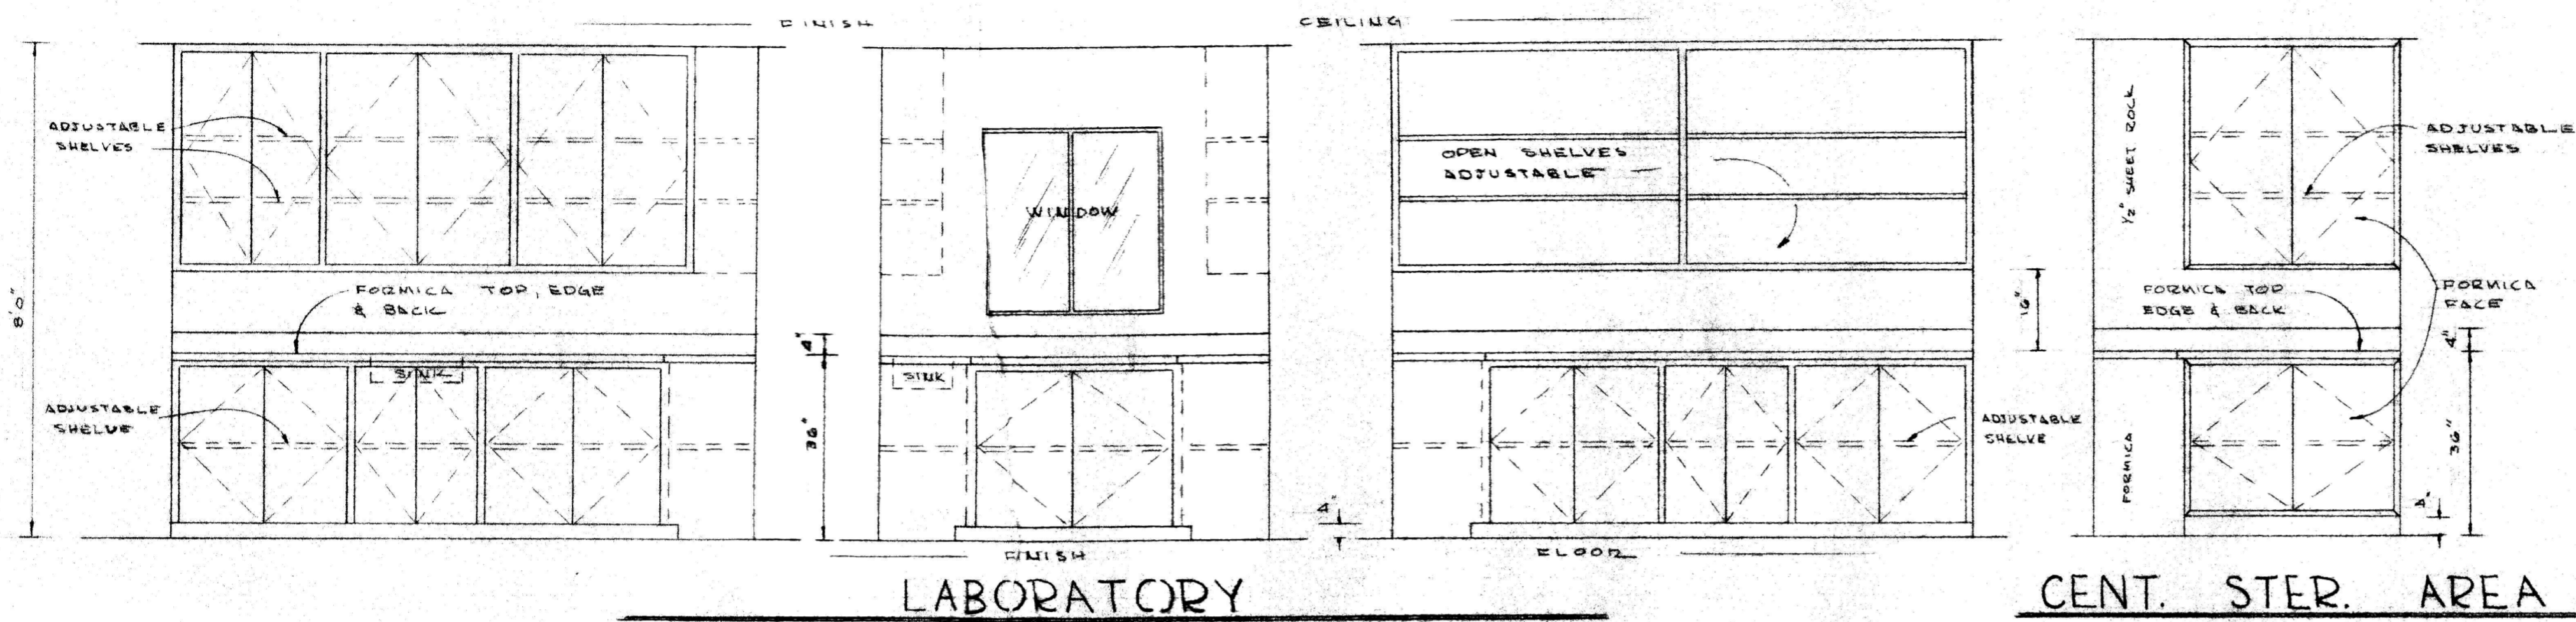

LABORATORY


CENT. STER. AREA

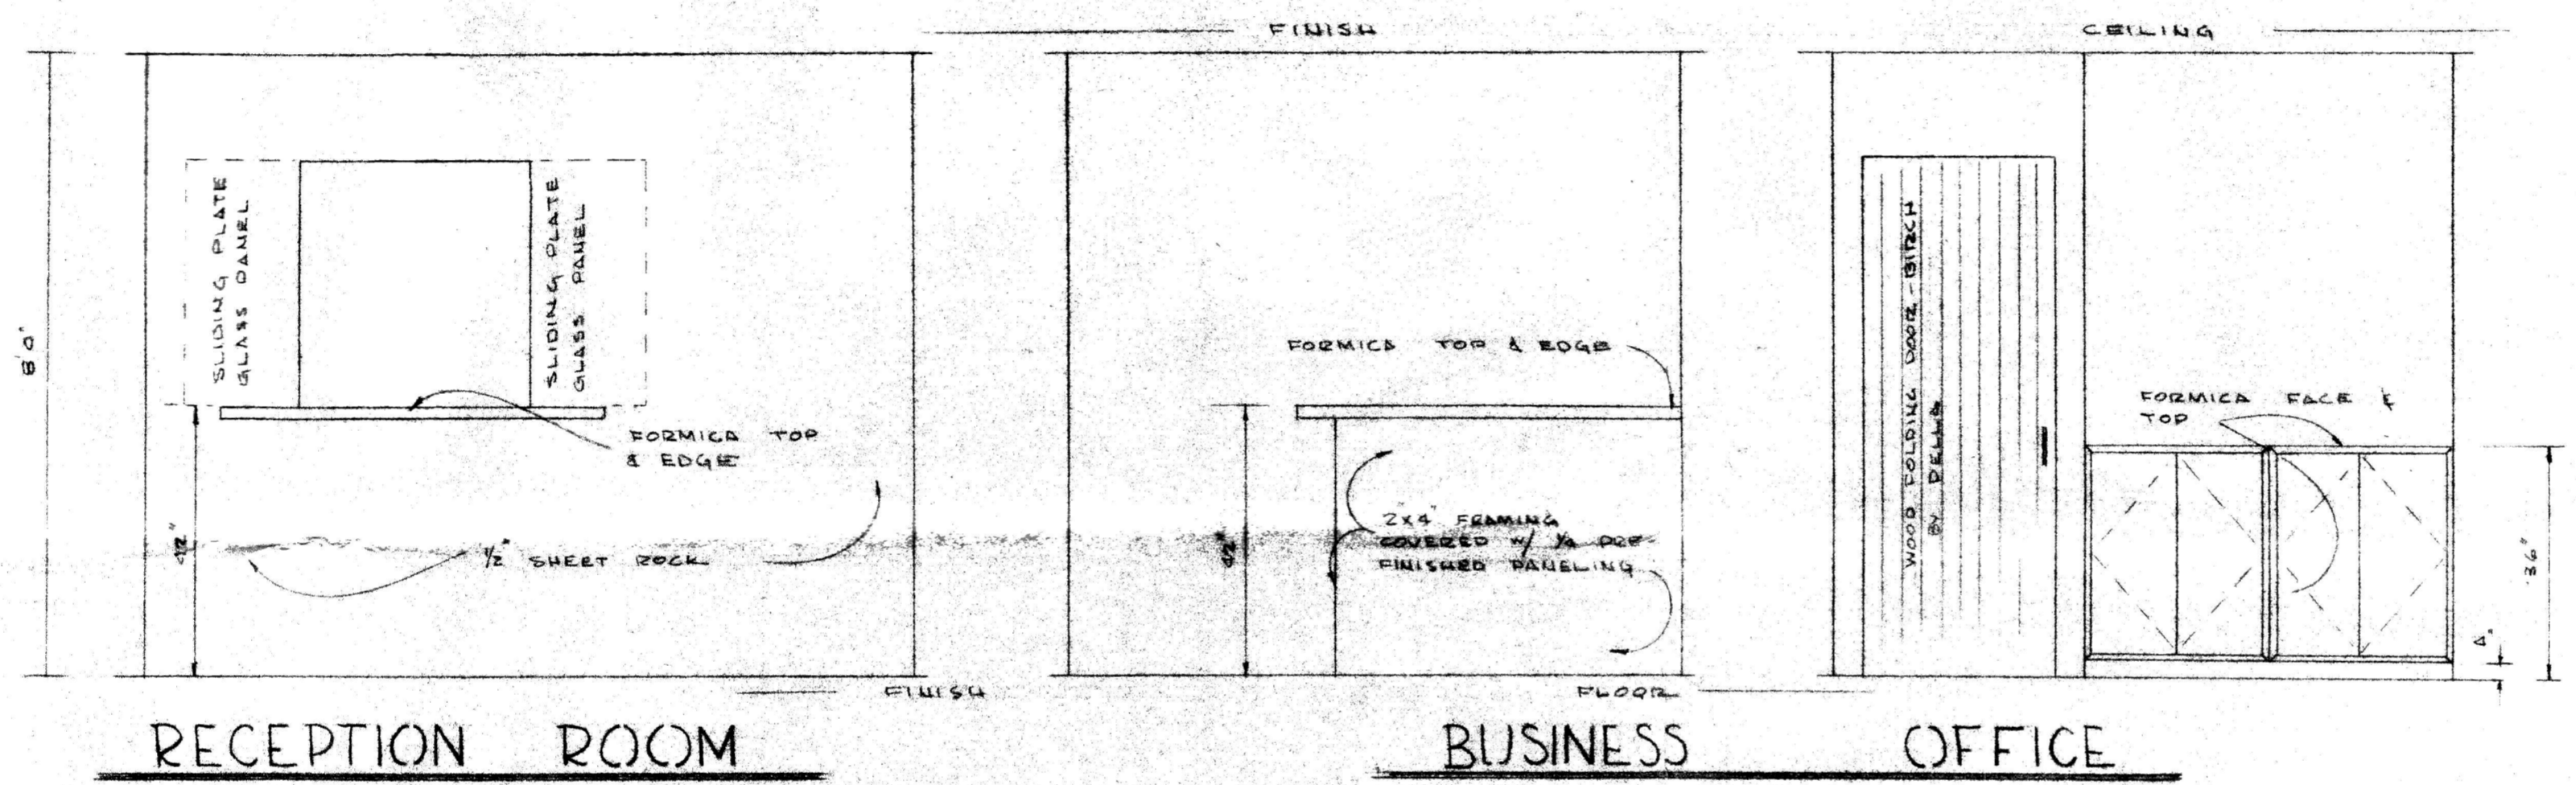

RECEPTION ROOM


BUSINESS

OFFICE

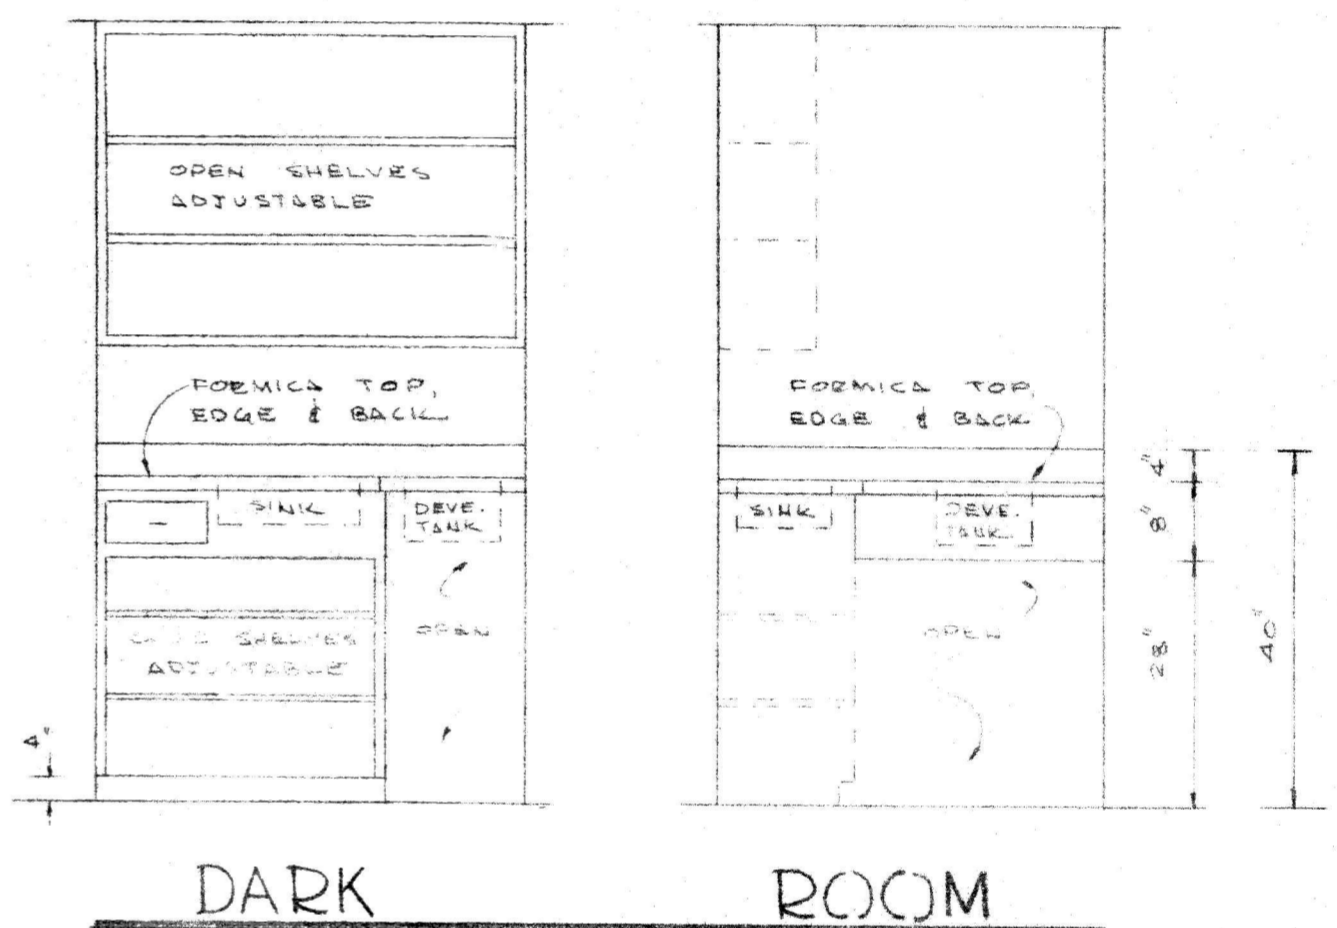


DARK

ROOM

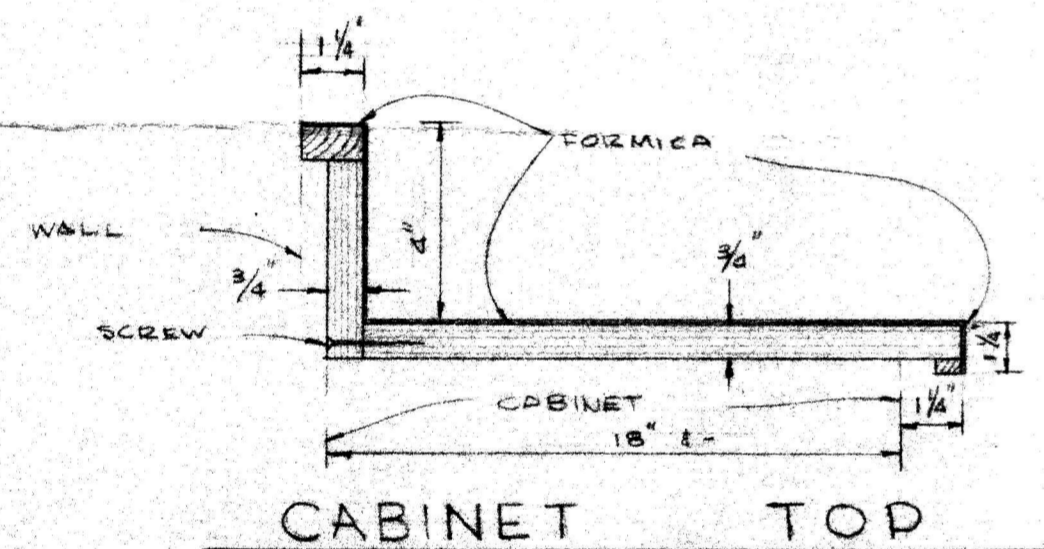


CABINET TOP

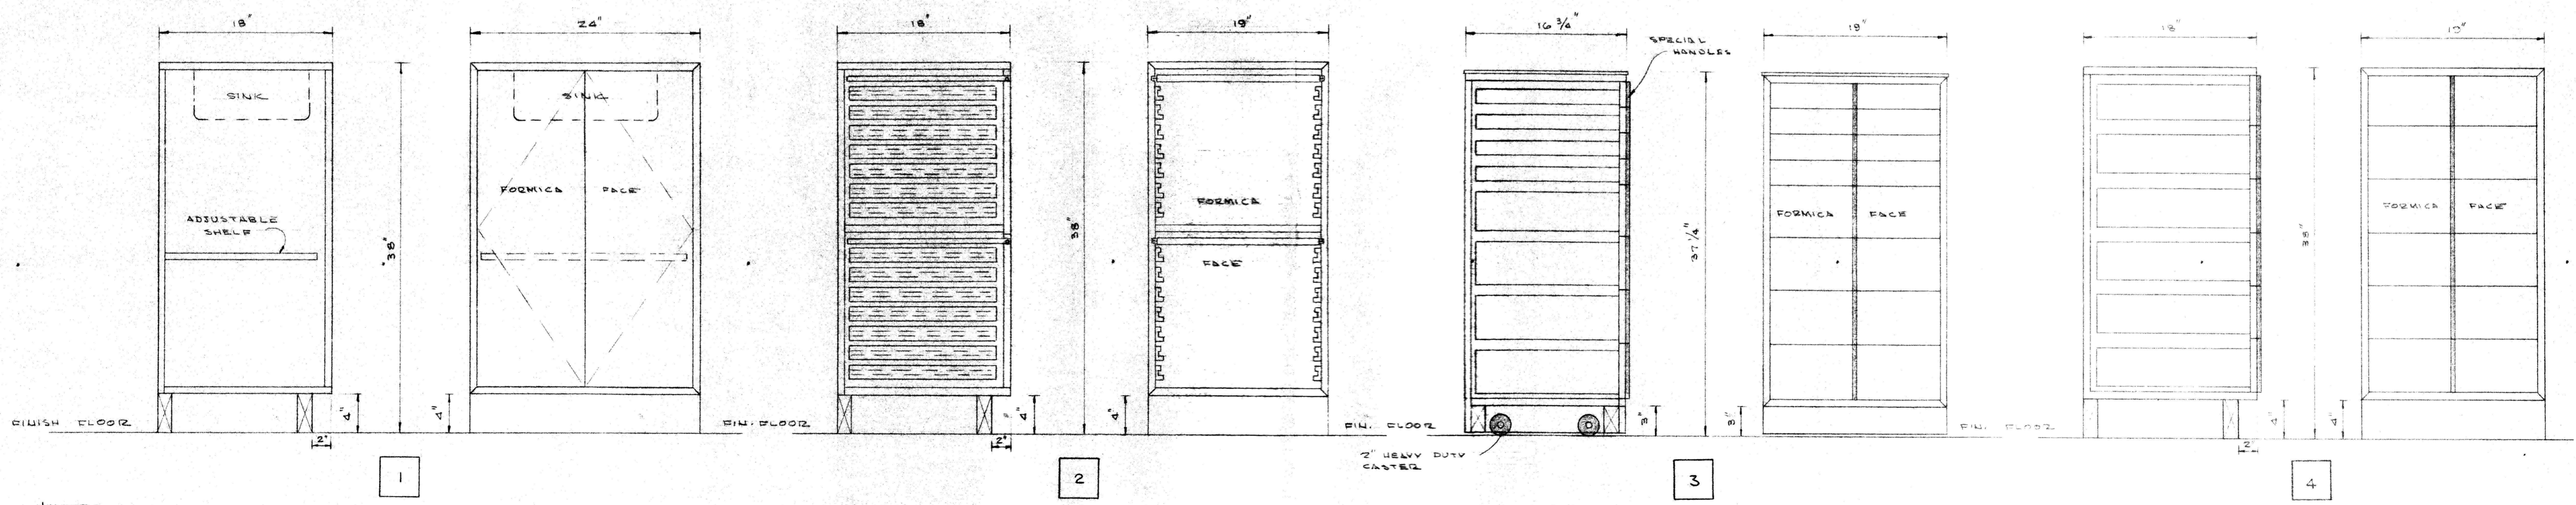

CABINET DETAILS



SCALE: 1/2" = 1'0"

NOTE:  
 QUANTITY  
 CONSTRUCT - 1 - 1  
 CONSTRUCT - 1 - 2  
 CONSTRUCT - 1 - 3  
 CONSTRUCT - 3 - 4  
 SEE CABINETS IN DR. SAGE'S  
 OFFICE BEFORE STARTING CONSTRUCTION

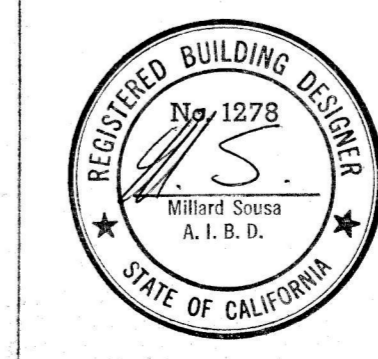

DATE: 3-24-67  
 DRAWN BY: M.S. 1278  
 JOB NO.  
 SHEET NO. 4  
 OF 4

CAMBRIA CLINIC ADDITION  
 CAMBRIA HOSPITAL DISTRICT  
 MILLARD SOUZA, A.I.B.D.  
 PHONE: 995-3305  
 CAYUCOS, CALIFORNIA

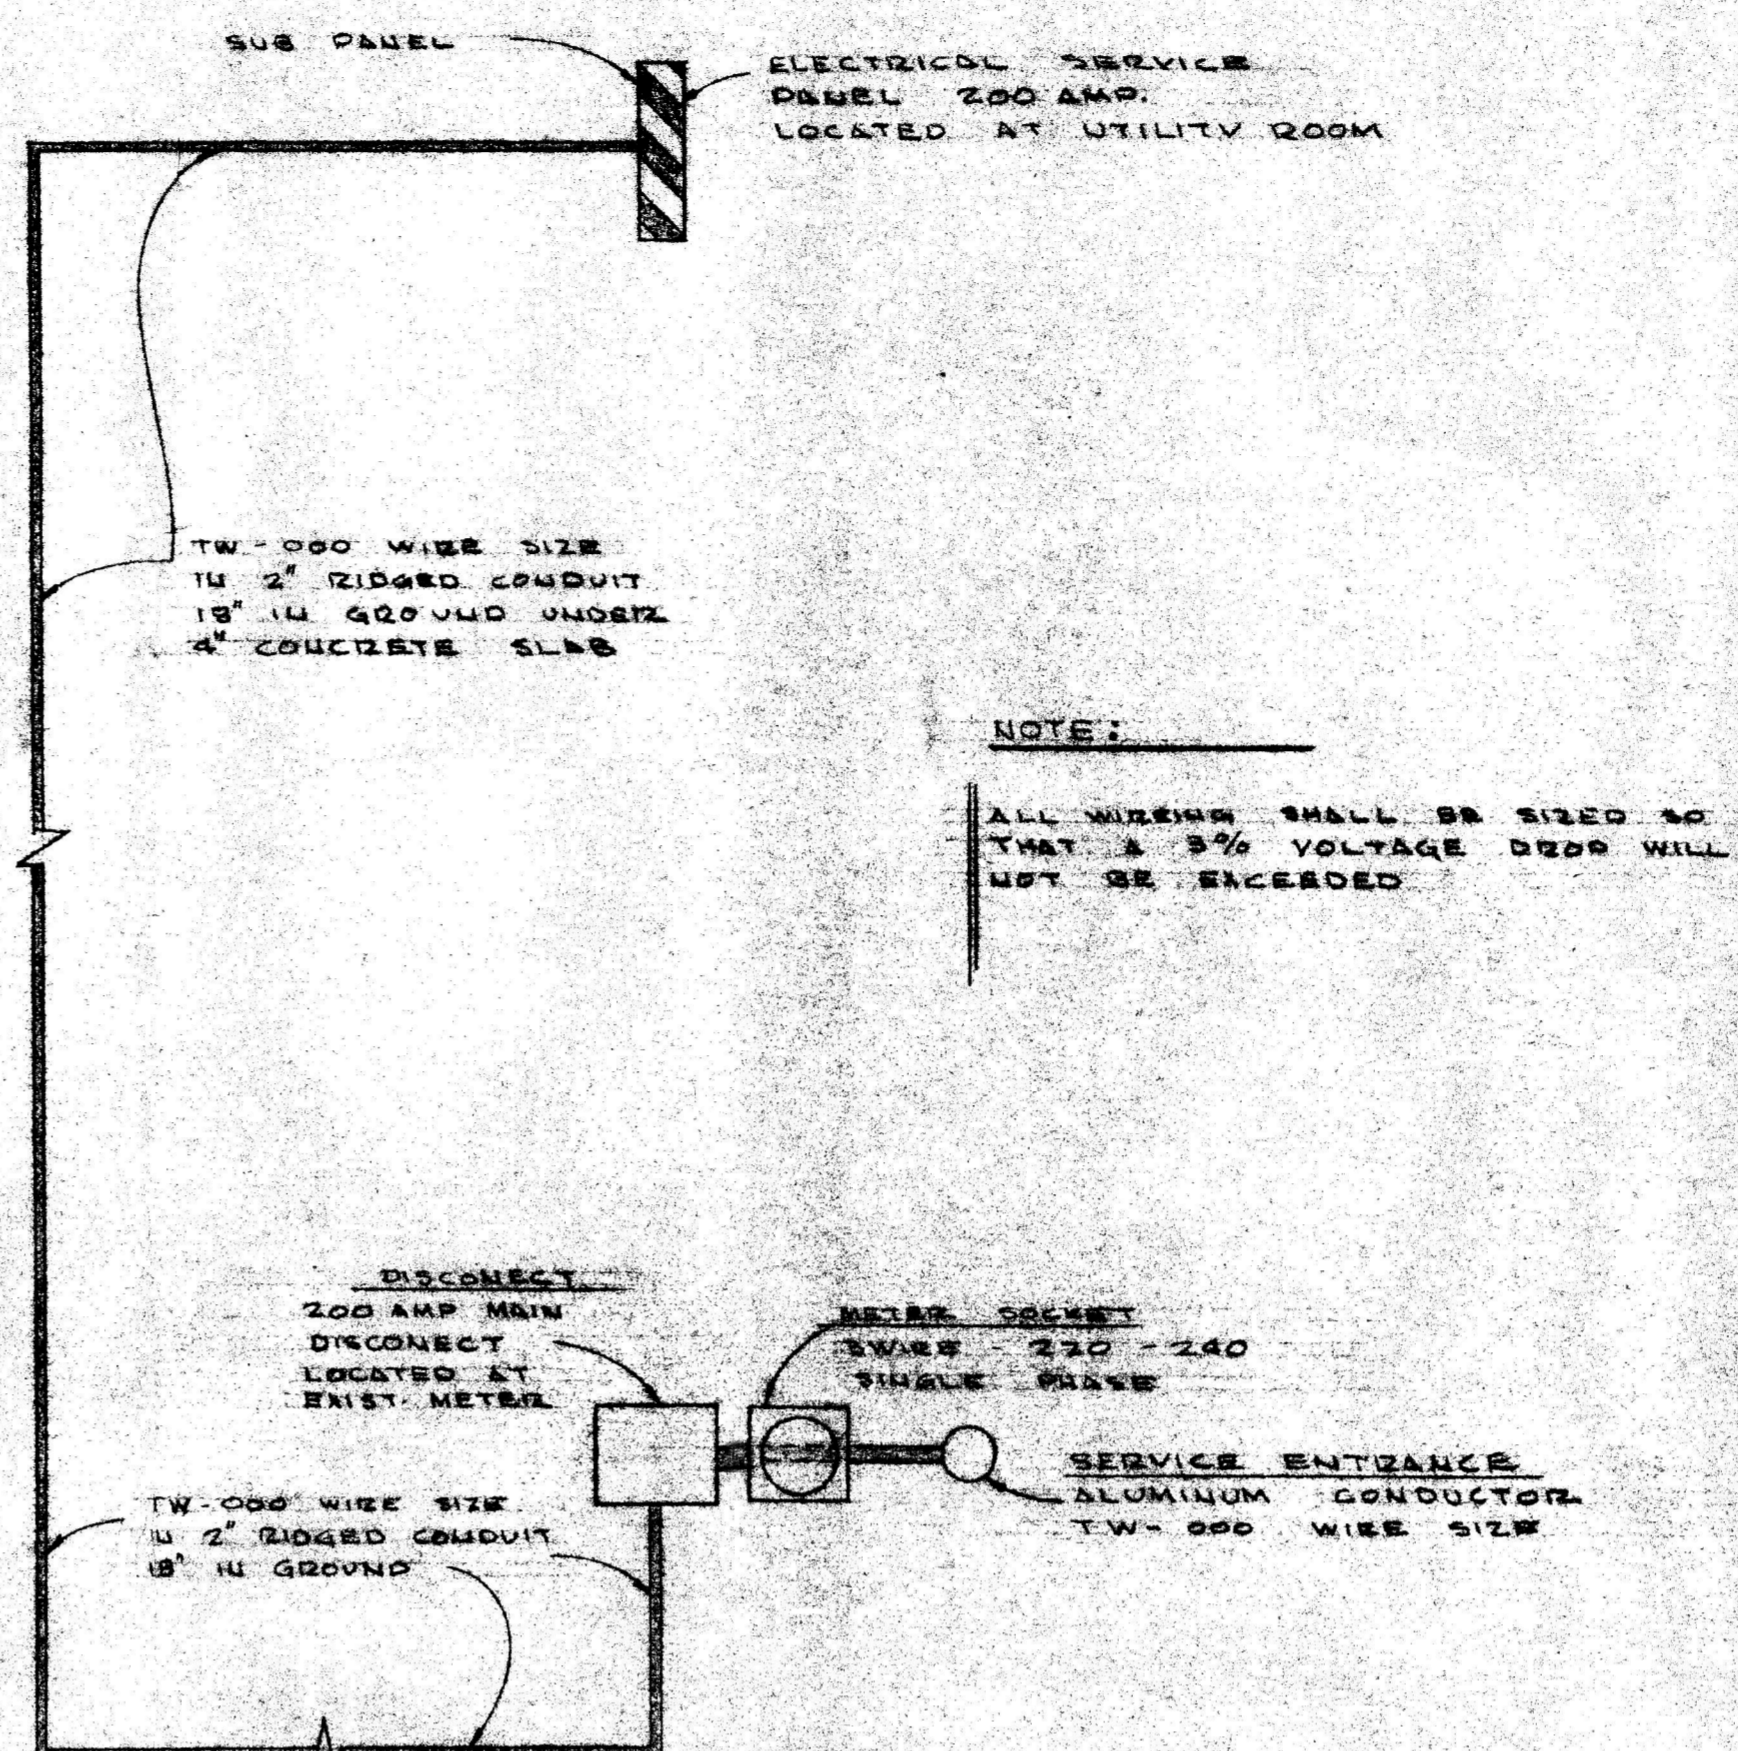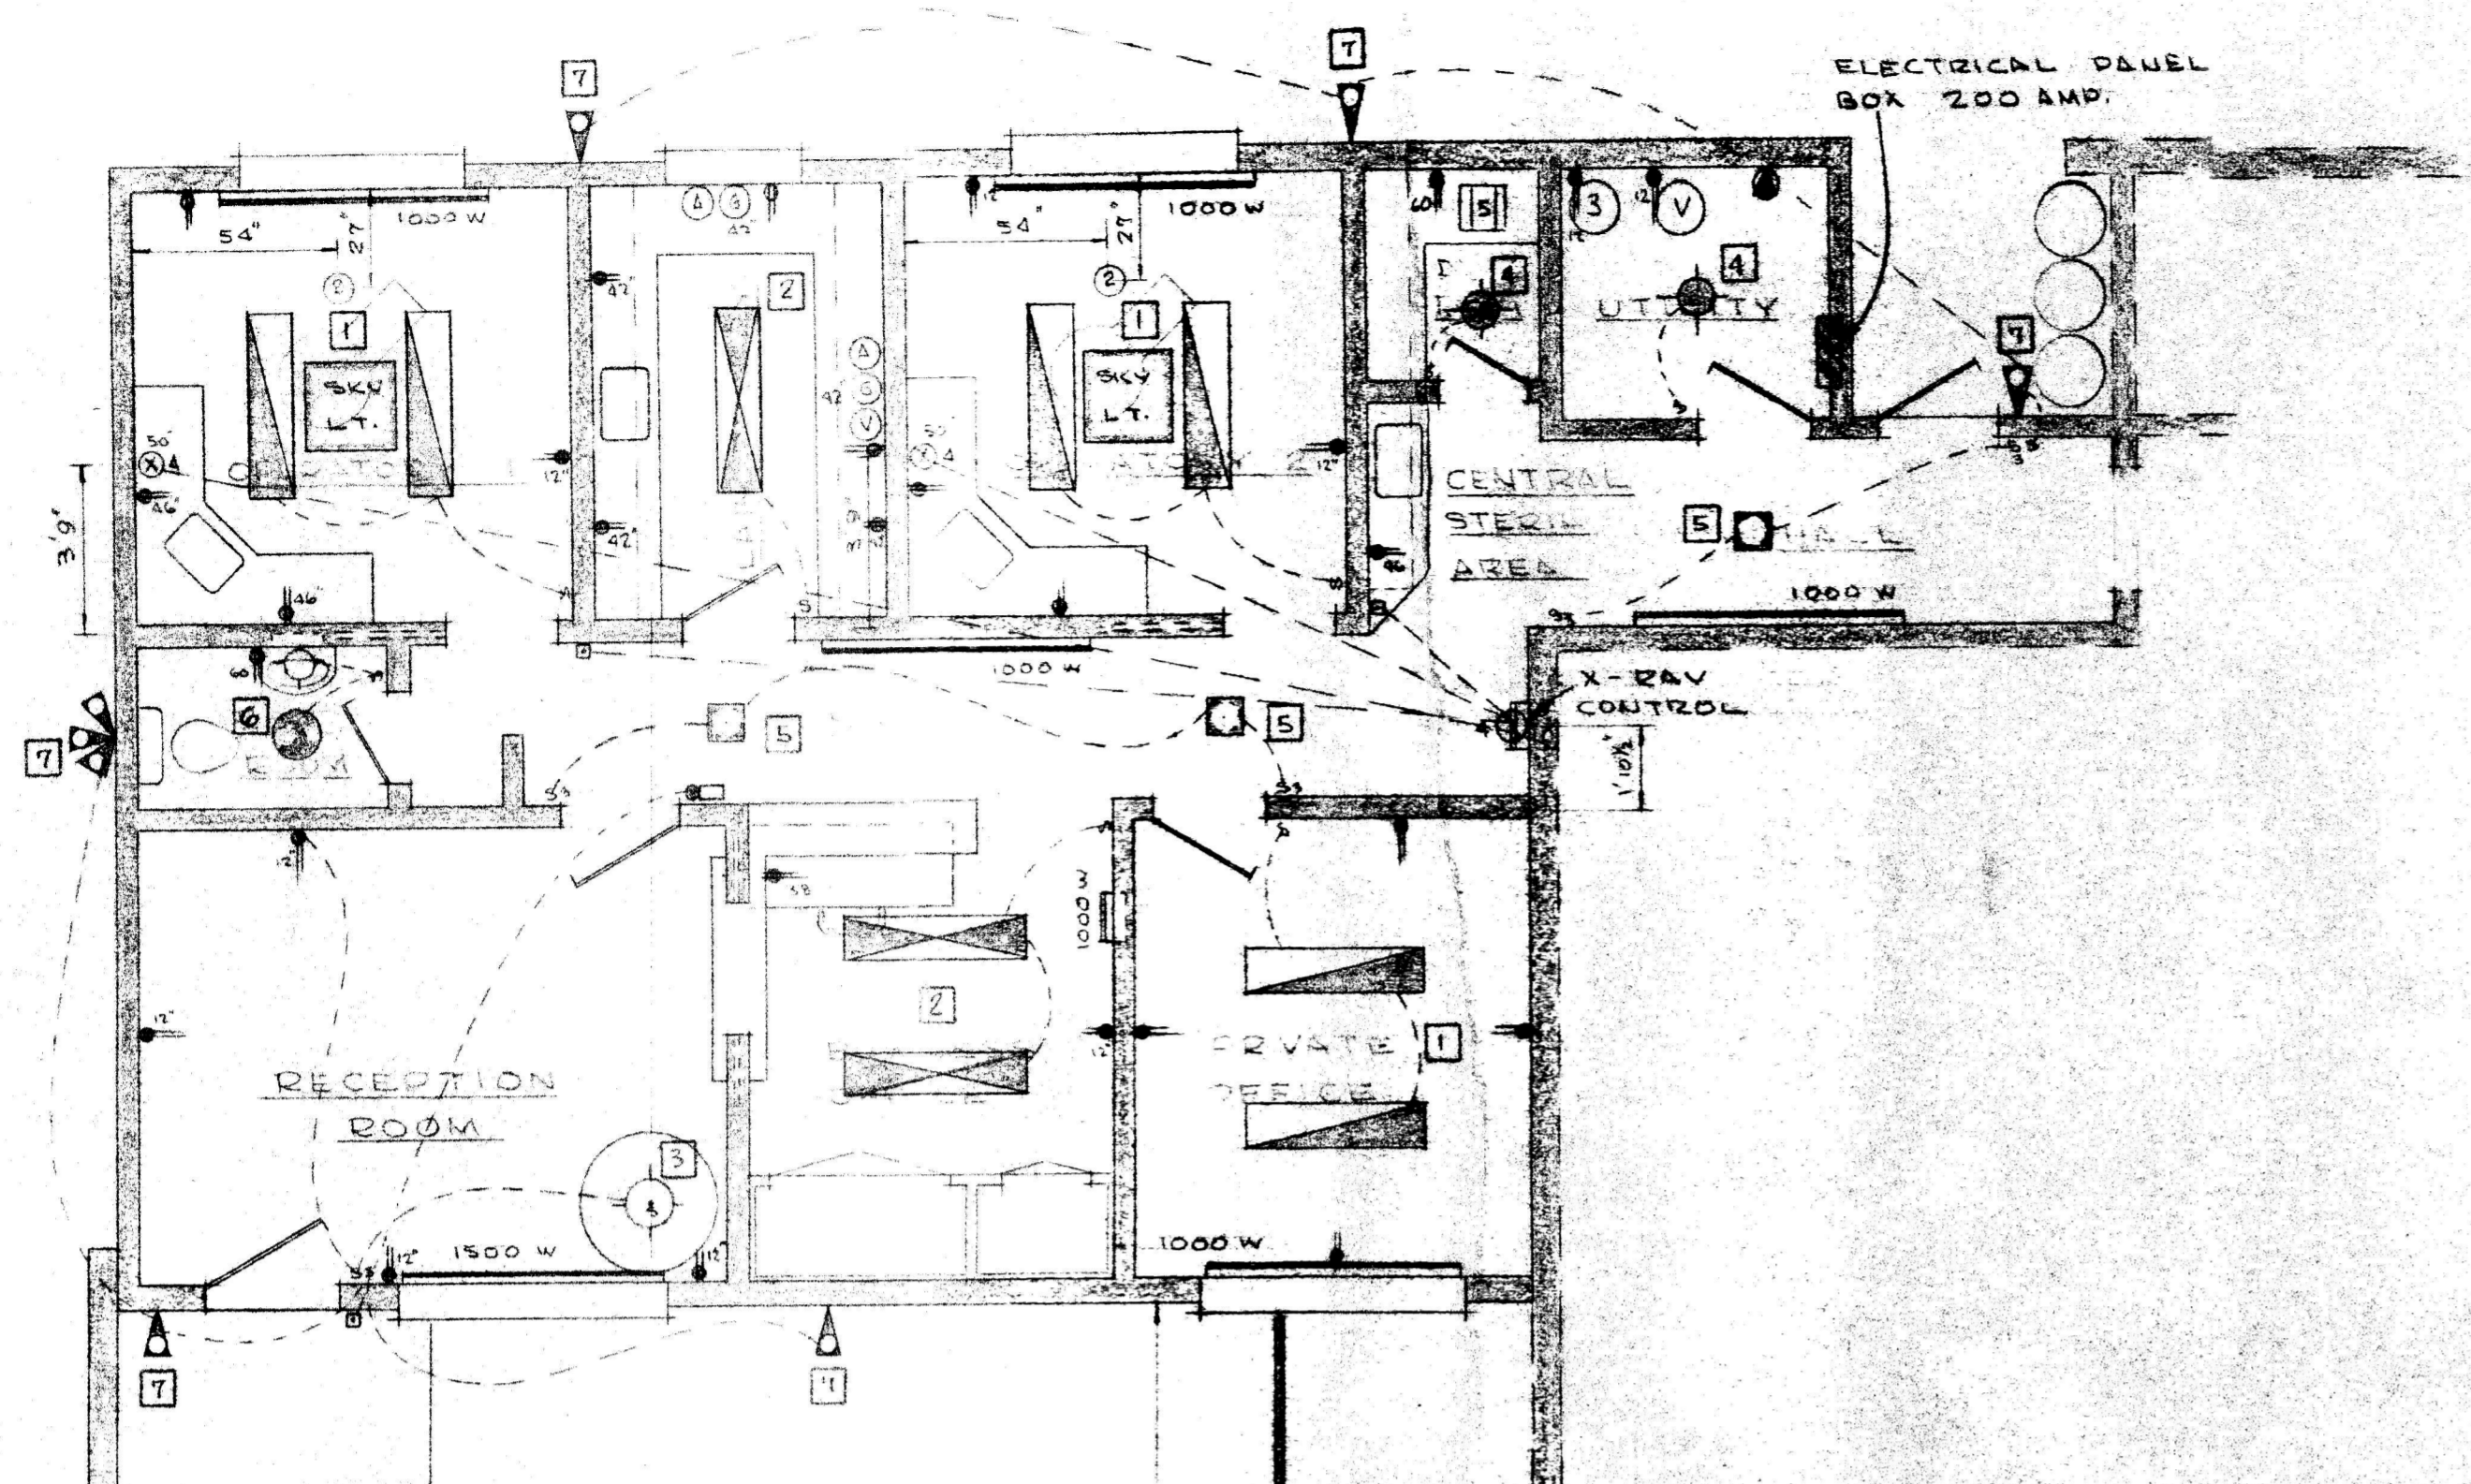


MAIN SERVICE DIAGRAM

ELECTRICAL PLAN

SCALE: 1/4" = 1' 0"

LOC.	SYM.	FIXTURE DESCRIPTION	SCHEDULE REMARKS
1	[Symbol]	CA-2124-4 BENJAMIN	MOUNT 8'6" ABOVE FINISH FLOOR IN PRIVATE OFFICE
2	[Symbol]	CA-2144-4	MOUNT 8'6" ABOVE FINISH FLOOR IN BUSINESS OFFICE
3	[Symbol]	M 2506 - 34 MDE	THIS FIXTURE TO BE SPOTTED BY DR. SAGE OR DESIGNER
4	[Symbol]	M 1512 - 78 W. - 276 WATT. MDE	
5	[Symbol]	R 21-A MDE	FLUSH CEILING OUTLET
6	[Symbol]	R 2-30Z MDE	VENTILATING FAN W/ RECESSED LIGHT
7	[Symbol]	M 4841 - 8 MDE	
	[Symbol]	220V - RECEPTACLE	
	[Symbol]	DUPLEX WALL PLUG RECEPTACLE	
	[Symbol]	X-124V RECEPTACLE	
	[Symbol]	LIGHT SWITCH	
	[Symbol]	3-WAY LIGHT SWITCH	
	[Symbol]	PUSH BUTTON	DOOR CHIME & X-RAY
	[Symbol]	DOOR CHIME	
	[Symbol]	POWER PANEL 200 AMP.	
	[Symbol]	WESTINGHOUSE BASE BOARD 220V	THERMOSTAT ON HEATED
	[Symbol]	WESTINGHOUSE WALL HEATER 220V	THERMOSTAT ON HEATED
	[Symbol]	TELEPHONE	TELEPHONES TO BE SPOTTED BY DR. SAGE
LIGHTING & MISC.		HEATING	
110 V		220 V	
111 AMPS		51 AMPS	
13150 WATTS		7500 WATTS	
TOTAL WATTS = 20650			
TOTAL AMPS = 142			

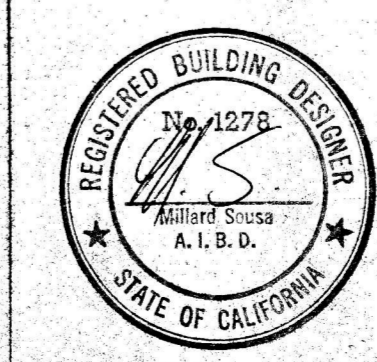

DATE: 3-24-67  
DRAWN BY: M.S. 1278  
JOB NO.  
SHEET NO. 1 OF 1

CAMBRIA CLINIC ADDITION  
CAMBRIA HOSPITAL DISTRICT  
MILLARD SOUZA, A.I.B.D.  
PHONE: 905-3308  
CAYUCOS, CALIFORNIA